 
 


WINDOW SCHEDULE			
MARK	TYPE	NOM. SIZE	NOTES
A	DOUBLE HUNG	2446	
B	AWNING	2424	
C	DOUBLE HUNG	21052	TO MEET EGRESS REQUIREMENTS

 SMOKE DETECTORS - INTERCONNECTED, HARD-WIRED W/ BATTERY BACK-UP AS PER CODE
 CARBON MONOXIDE DETECTOR

1 Garden Level Plan
 Scale: 1/4"=1'-0"


JONATHAN RAISZ
 ARCHITECT
 26 THORNDIKE STREET
 BROOKLINE, MA 02446
 PHONE (617) 734-1040
 RAISZ@RCN.COM

New 2 Family Residence
11 SPARHAWK STREET
 BRIGHTON, MASSACHUSETTS 02135

GARDEN LEVEL PLAN
 SCALE: 1/4"=1'-0"

DATE:
 DEC. 5, 2011
 REVISIONS:
 MAR. 1, 2012

A1

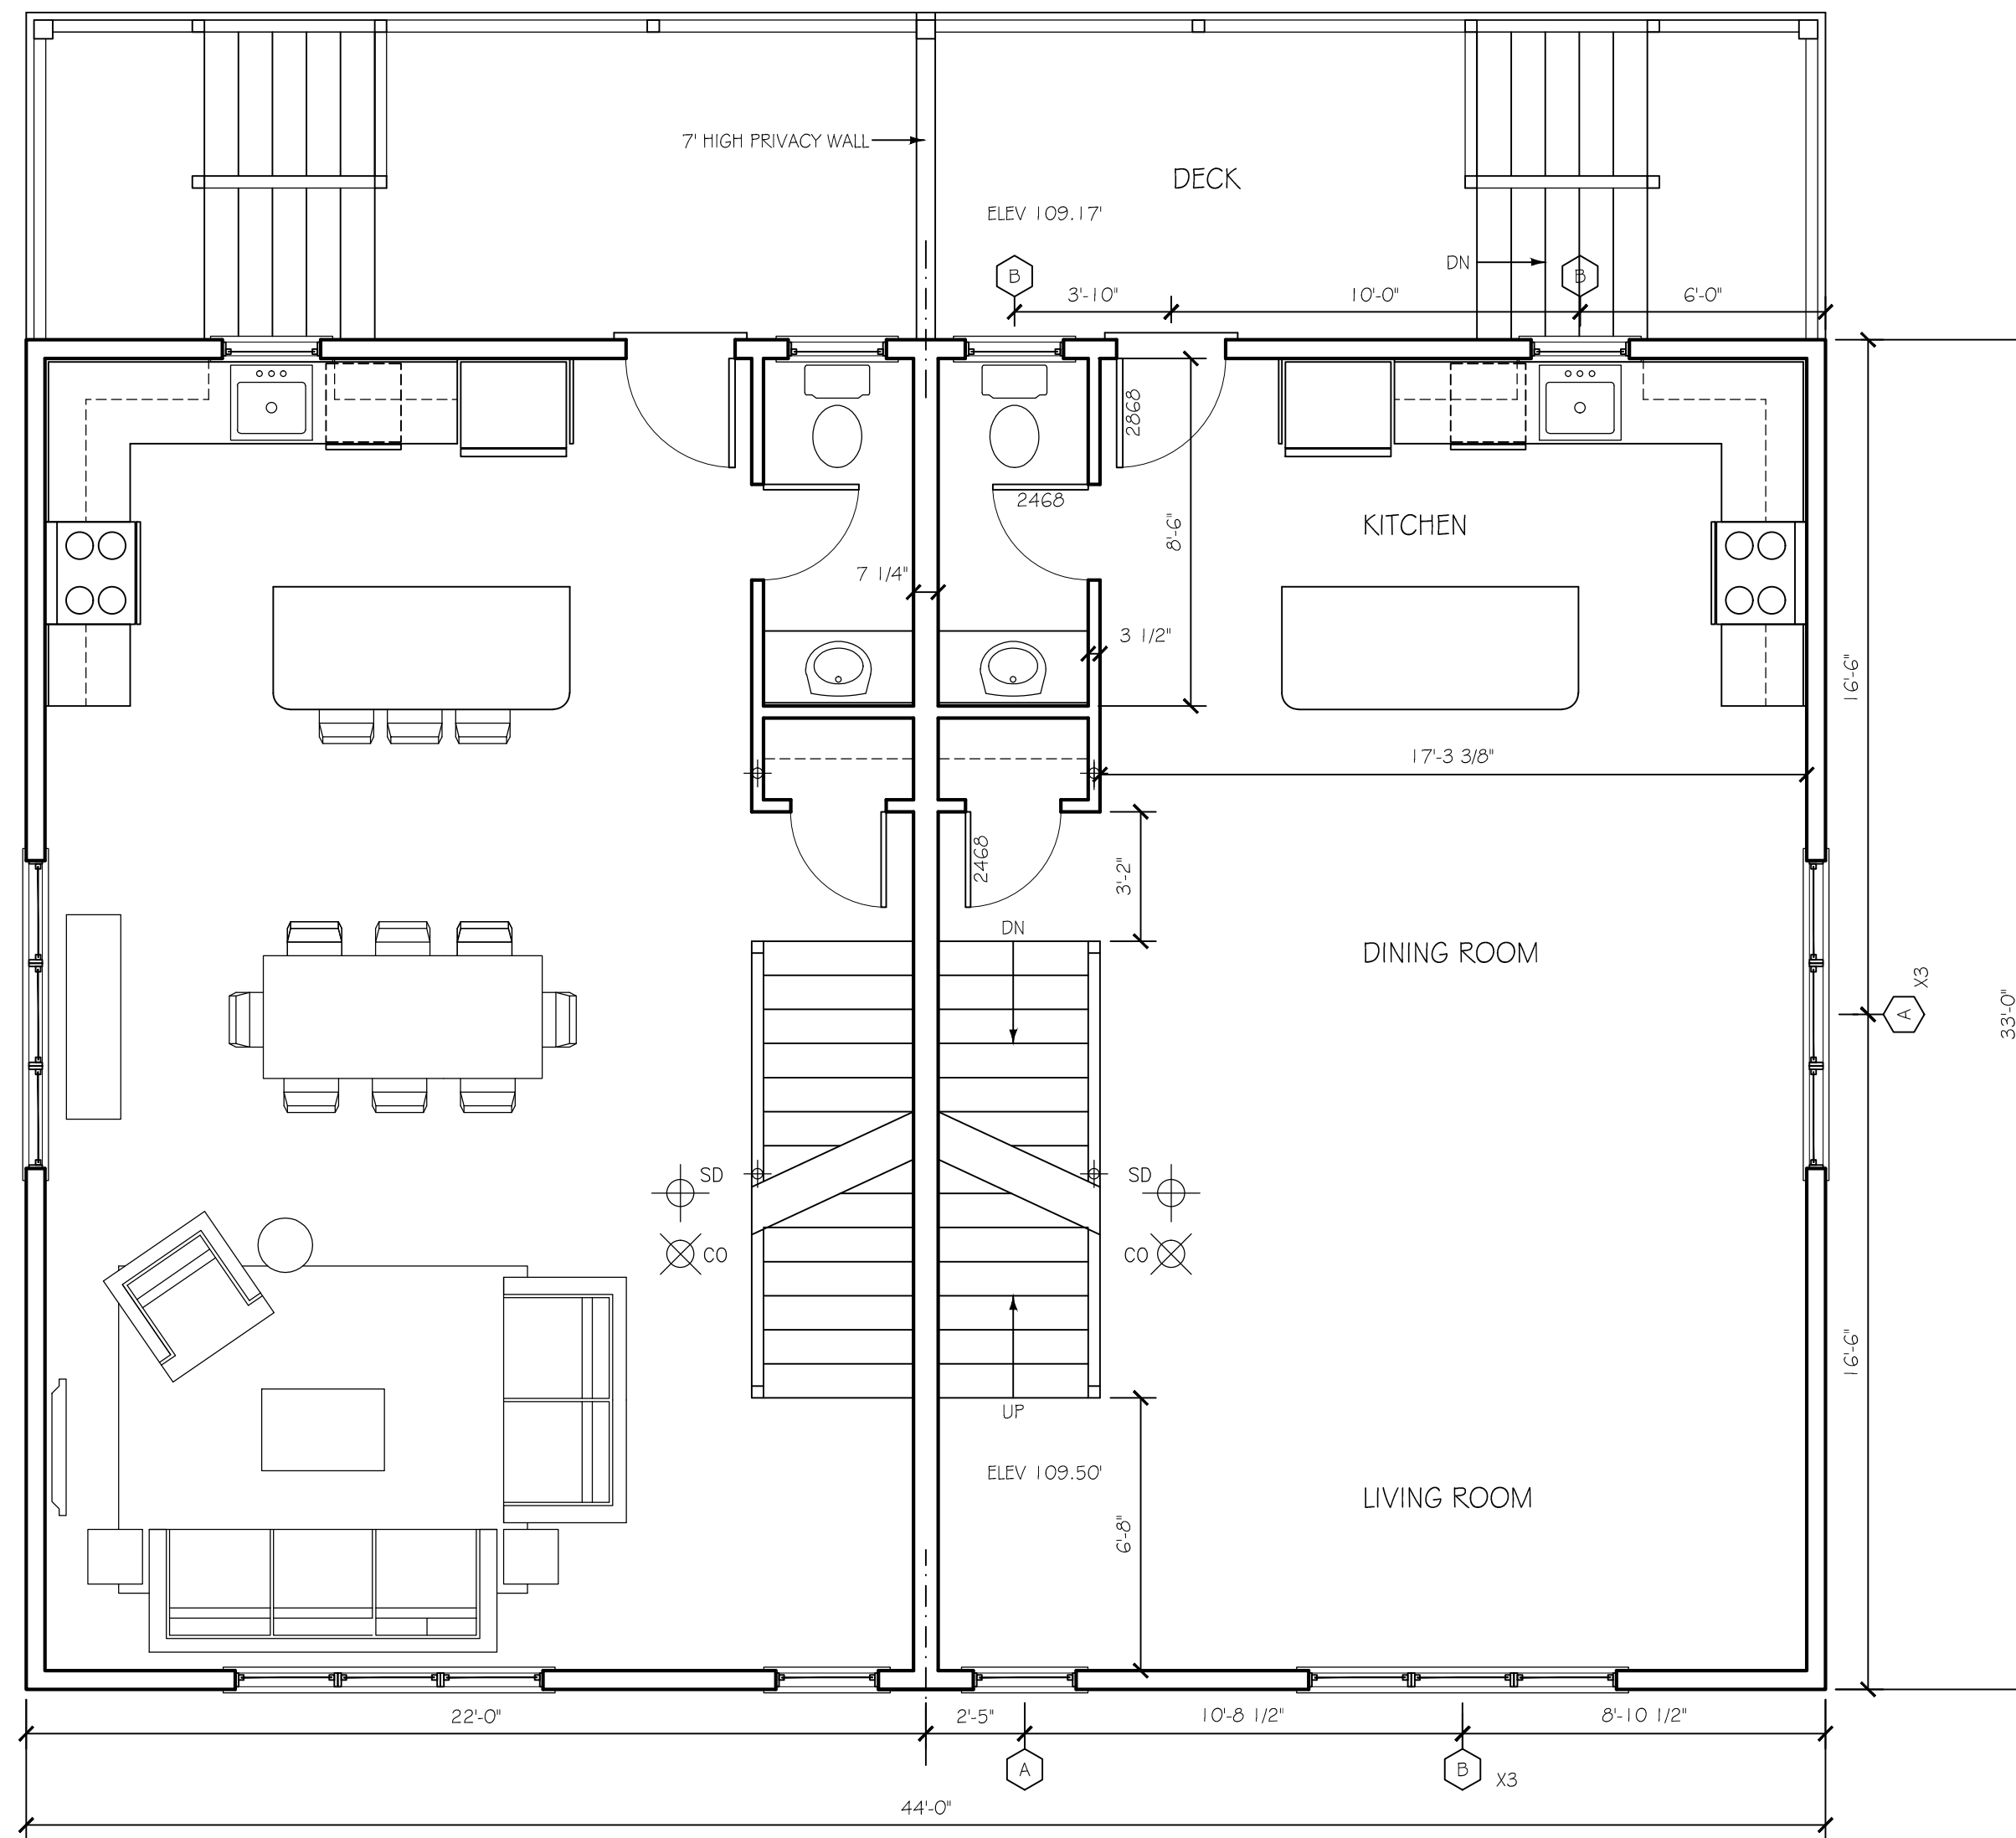

SD ⊕ SMOKE DETECTORS -
 INTERCONNECTED, HARD-WIRED W/
 BATTERY BACK-UP AS PER CODE
 CO ⊗ CARBON MONOXIDE DETECTOR

1 1st Floor Plan
 Scale: 1/4"=1'-0"


JONATHAN RAISZ
 ARCHITECT
 26 THORNDIKE STREET
 BROOKLINE, MA 02446
 PHONE (617) 734-1040
 RAISZ@RCN.COM

New 2 Family Residence
11 SPARHAWK STREET
 BRIGHTON, MASSACHUSETTS 02135

FIRST FLOOR PLAN
 SCALE: 1/4"=1'-0"

DATE:
 DEC. 5, 2011
 REVISIONS:
 MAR. 1, 2012

A2

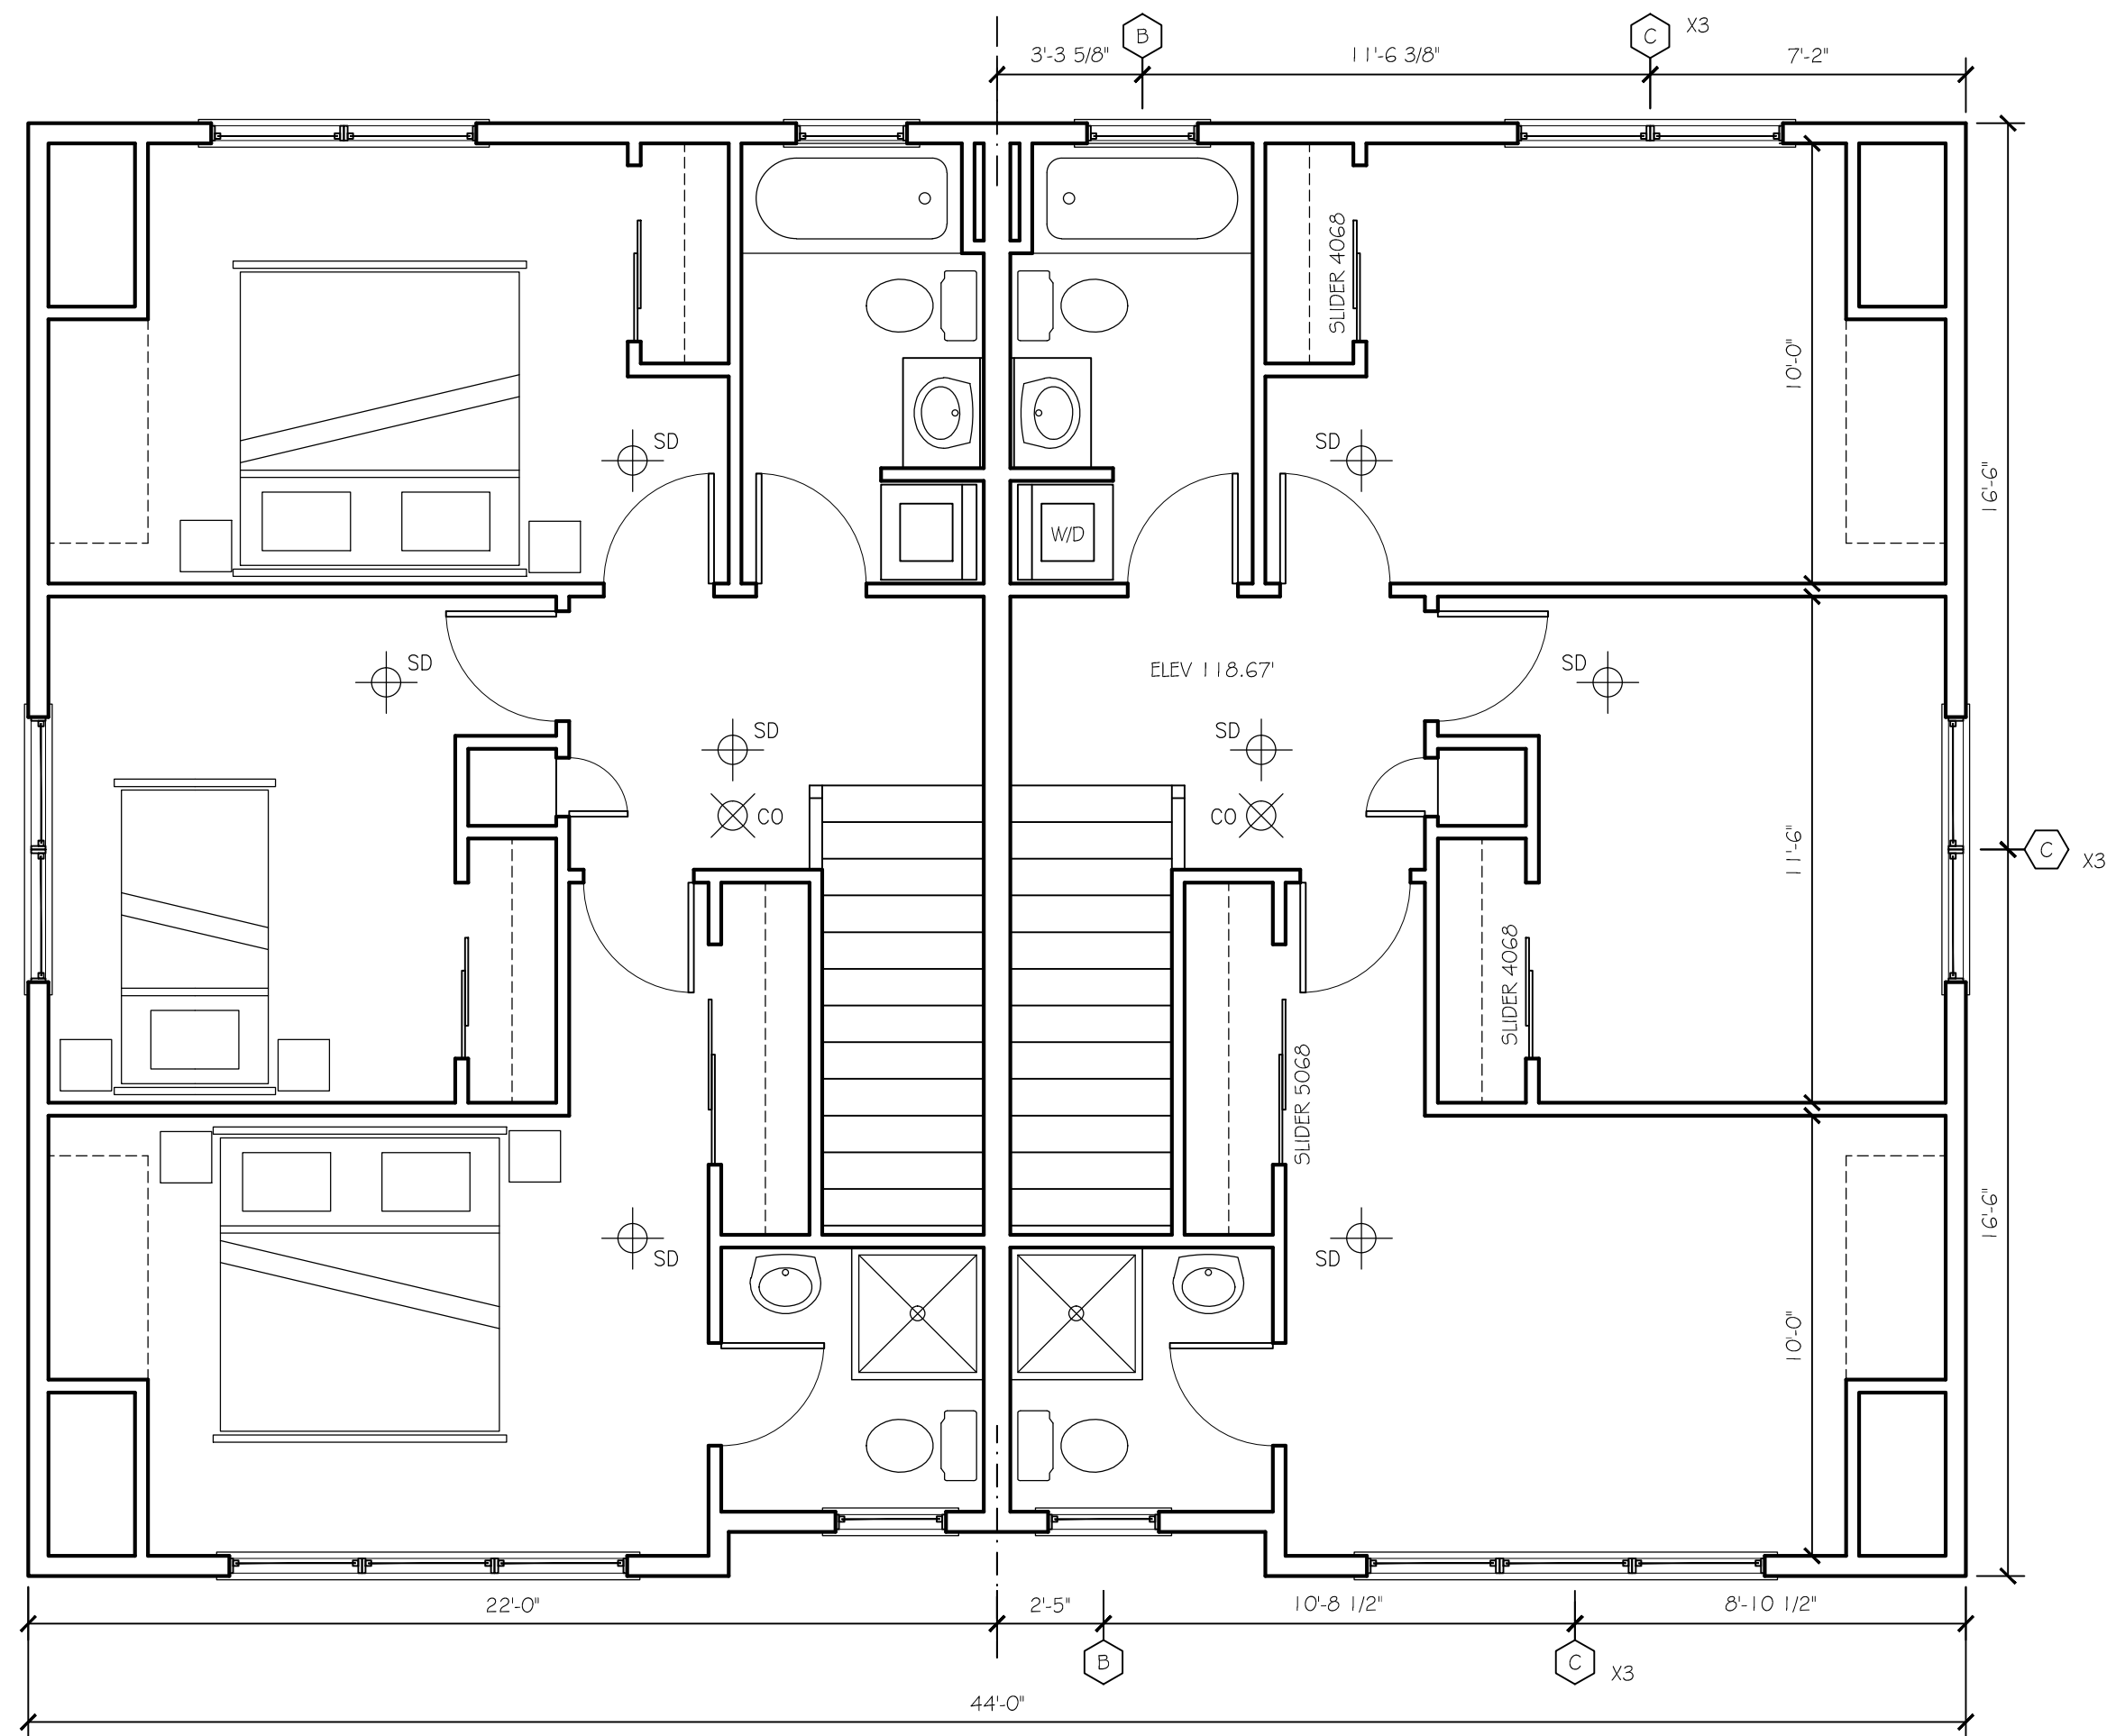

SD SMOKE DETECTORS -
 INTERCONNECTED, HARD-WIRED W/
 BATTERY BACK-UP AS PER CODE
 CO CARBON MONOXIDE DETECTOR

1 **2nd Floor Plan**
 Scale: 1/4"=1'-0"

JONATHAN RAISZ
 ARCHITECT
 26 THORNDIKE STREET
 BROOKLINE, MA 02446
 PHONE (617) 734-1040
 RAISZ@RCN.COM

New 2 Family Residence
11 SPARHAWK STREET
 BRIGHTON, MASSACHUSETTS 02135

**SECOND FLOOR
 PLAN**
 SCALE: 1/4"=1'-0"

DATE:
 DEC. 5, 2011
 REVISIONS:
 MAR. 1, 2012

A3